


Lake Felter

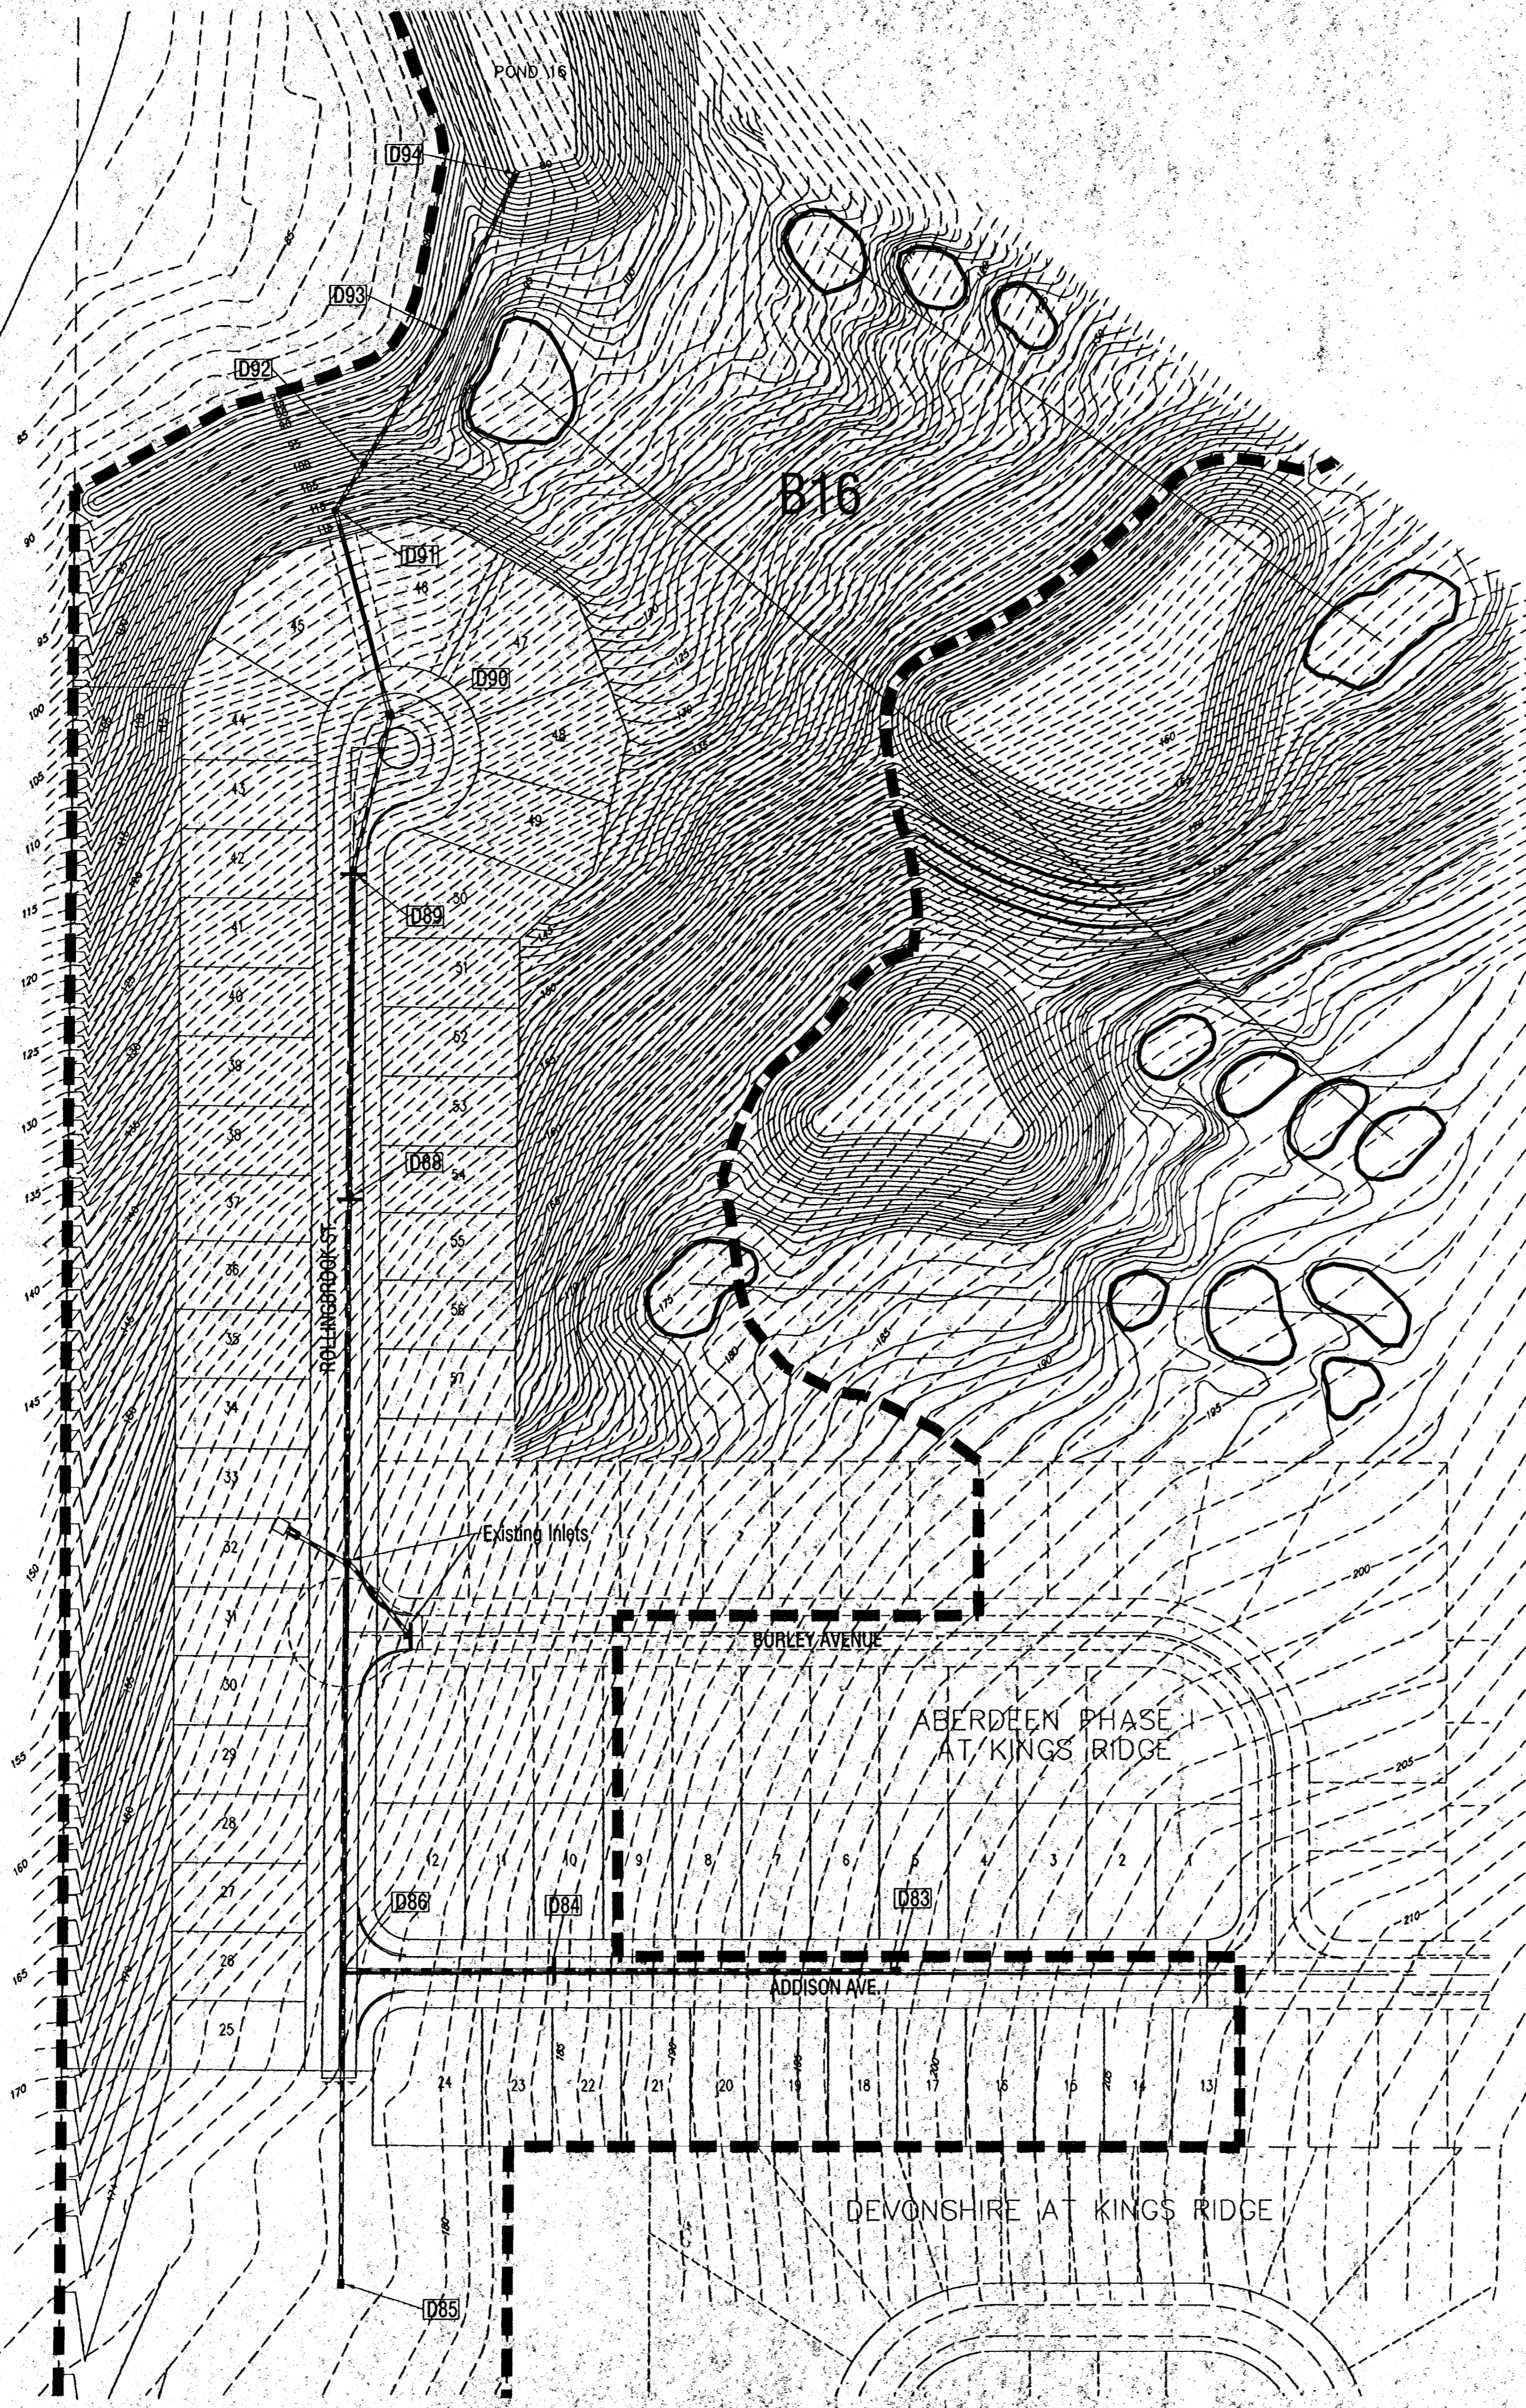

**LEGEND**

- D00 STORM STRUCTURE LABEL
- PROPOSED STORM SEWER
- - - EXISTING STORM SEWER
- B0** POST BASIN NUMBER
- - - - - POST BASIN DIVIDE

| DATE | REVISION |
|------|----------|
|      |          |
|      |          |
|      |          |
|      |          |
|      |          |





**FARNER BARLEY AND ASSOCIATES, INC.**  
 ENGINEERS SURVEYORS PLANNERS  
 350 North Sinclair Avenue • Tallahassee, Florida 32377 • (904) 343-8481

**MASTER DRAINAGE PLAN  
 ABERDEEN PHASE II  
 AT KINGS RIDGE**

CHECKED BY: \_\_\_\_\_  
 PROJECT NO.: 941216.104  
 DATE: APRIL 2000  
 DRAWN BY: J.M.  
**Sht. 3**  
 FILE NAME: \_\_\_\_\_

#11

RECEIVED  
 AUG 17 2000  
 40-069-19411-11  
 AUG 16 2000

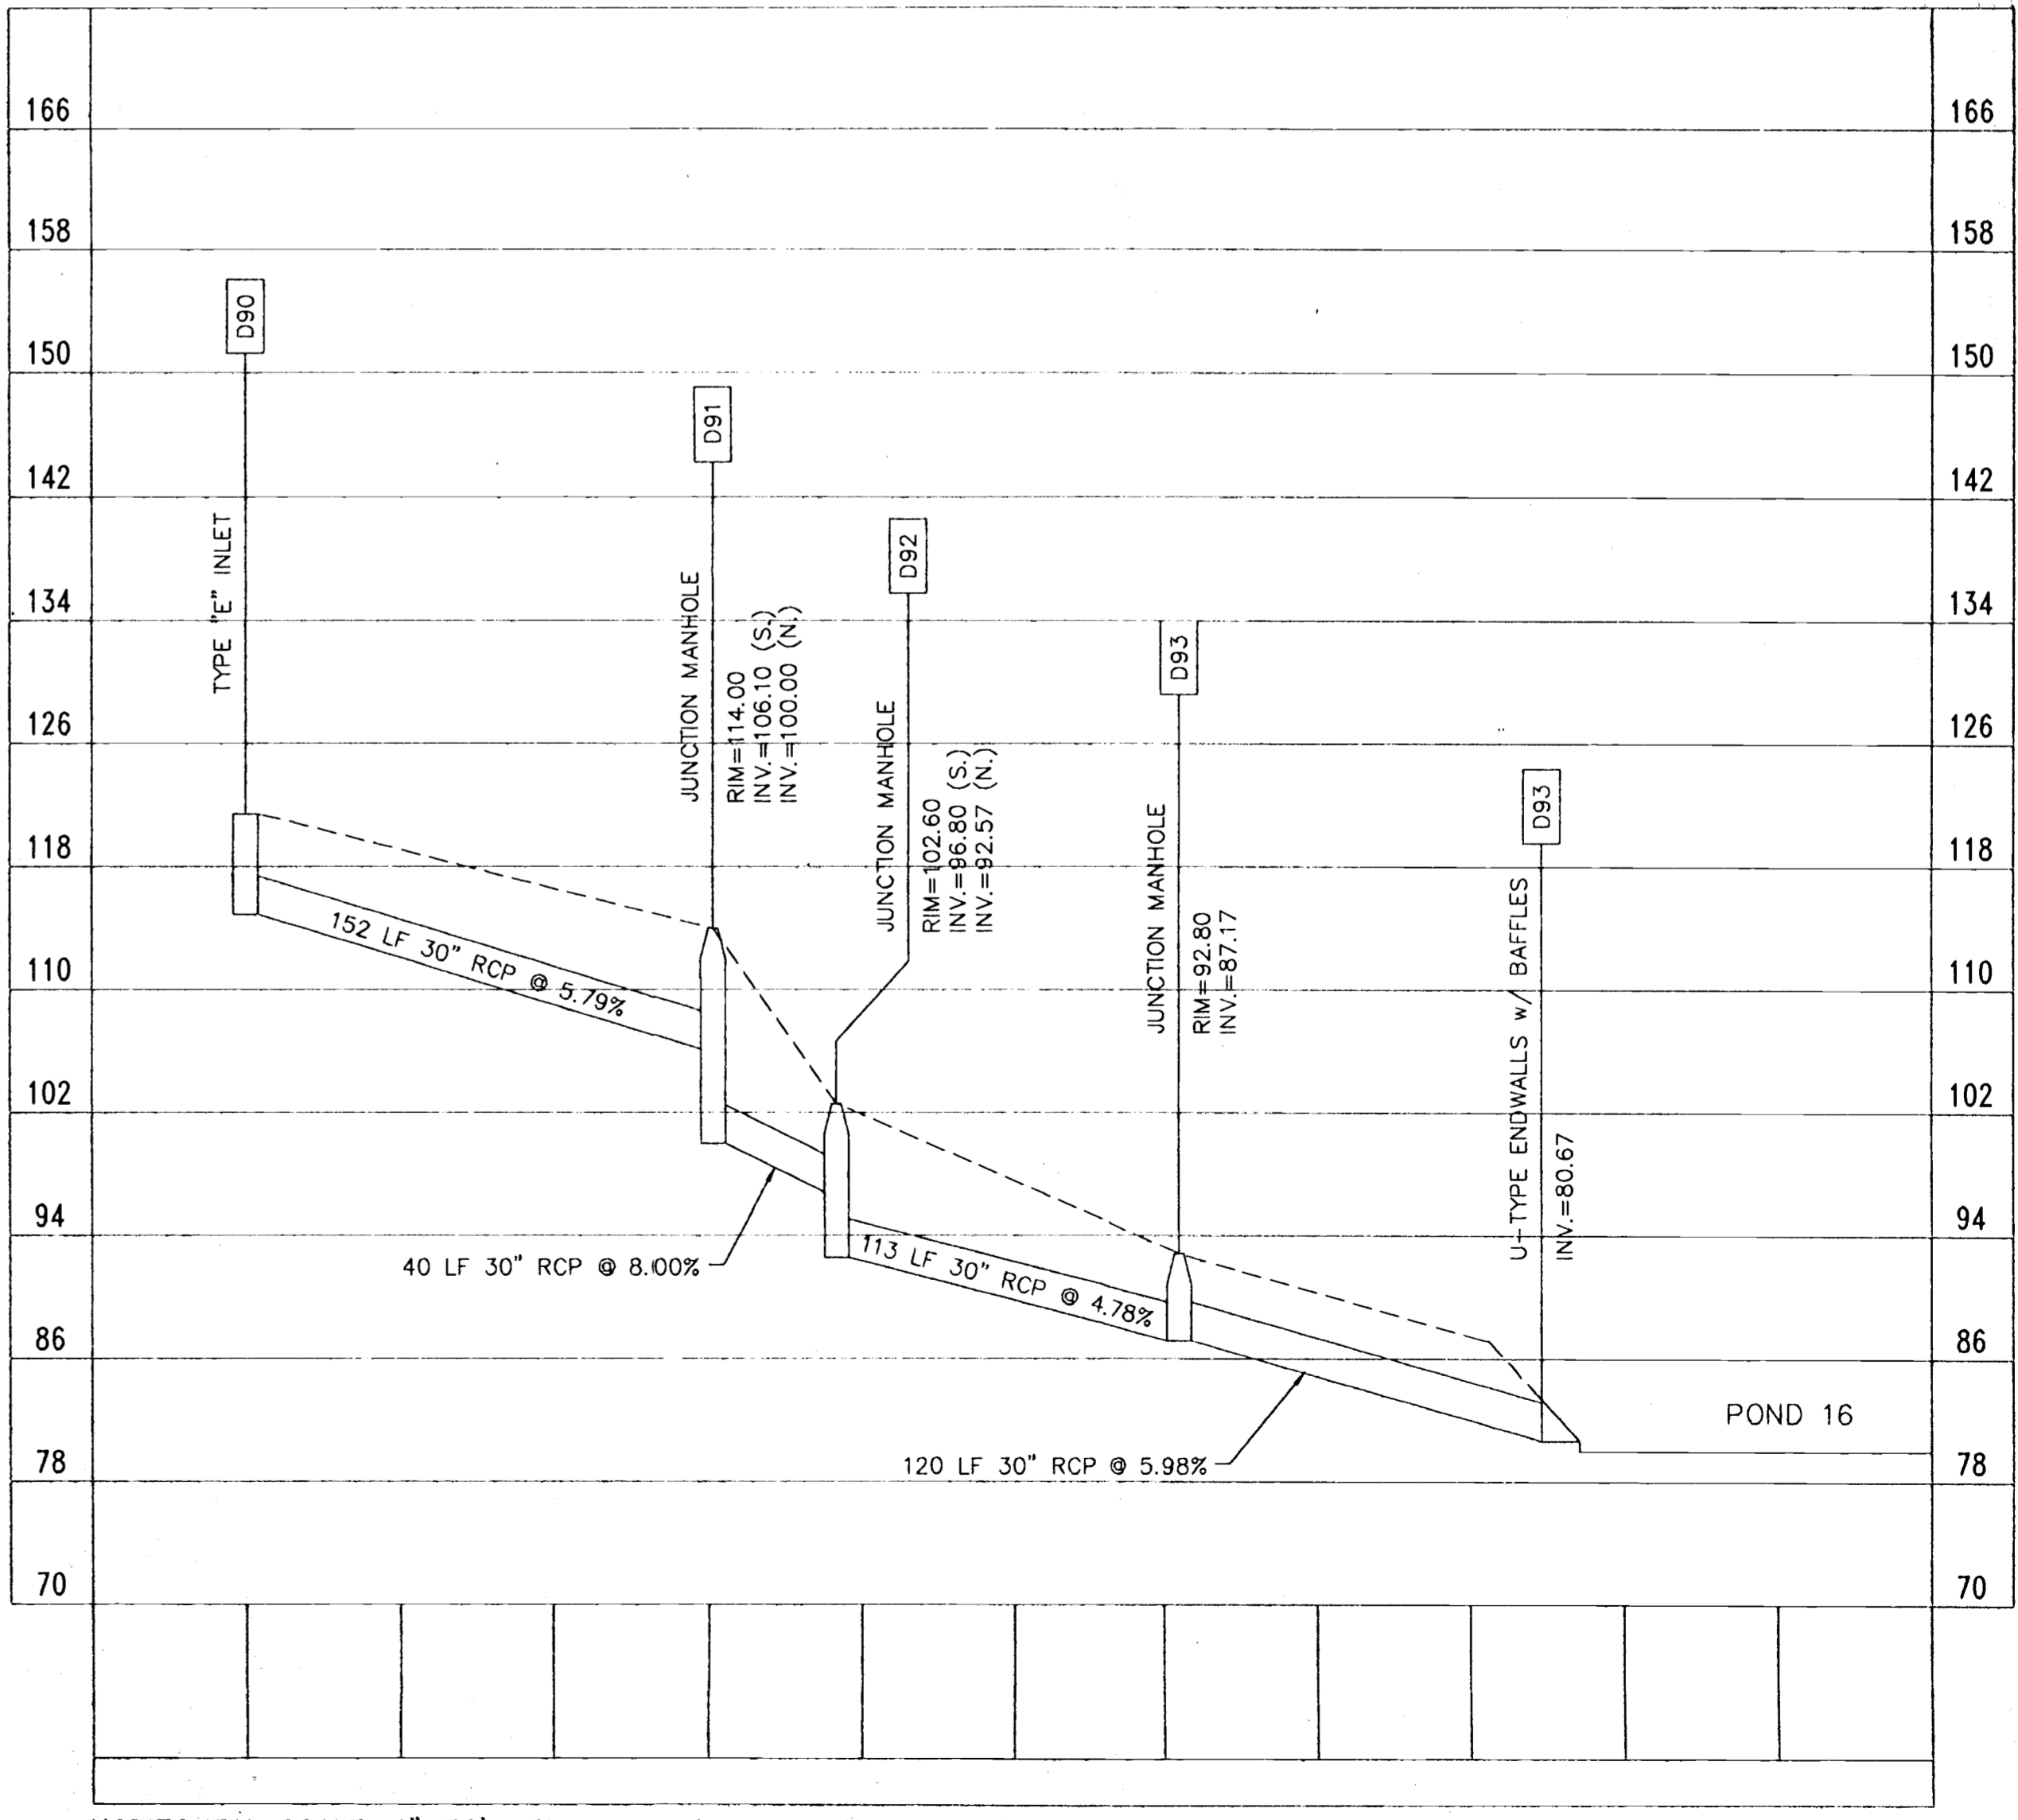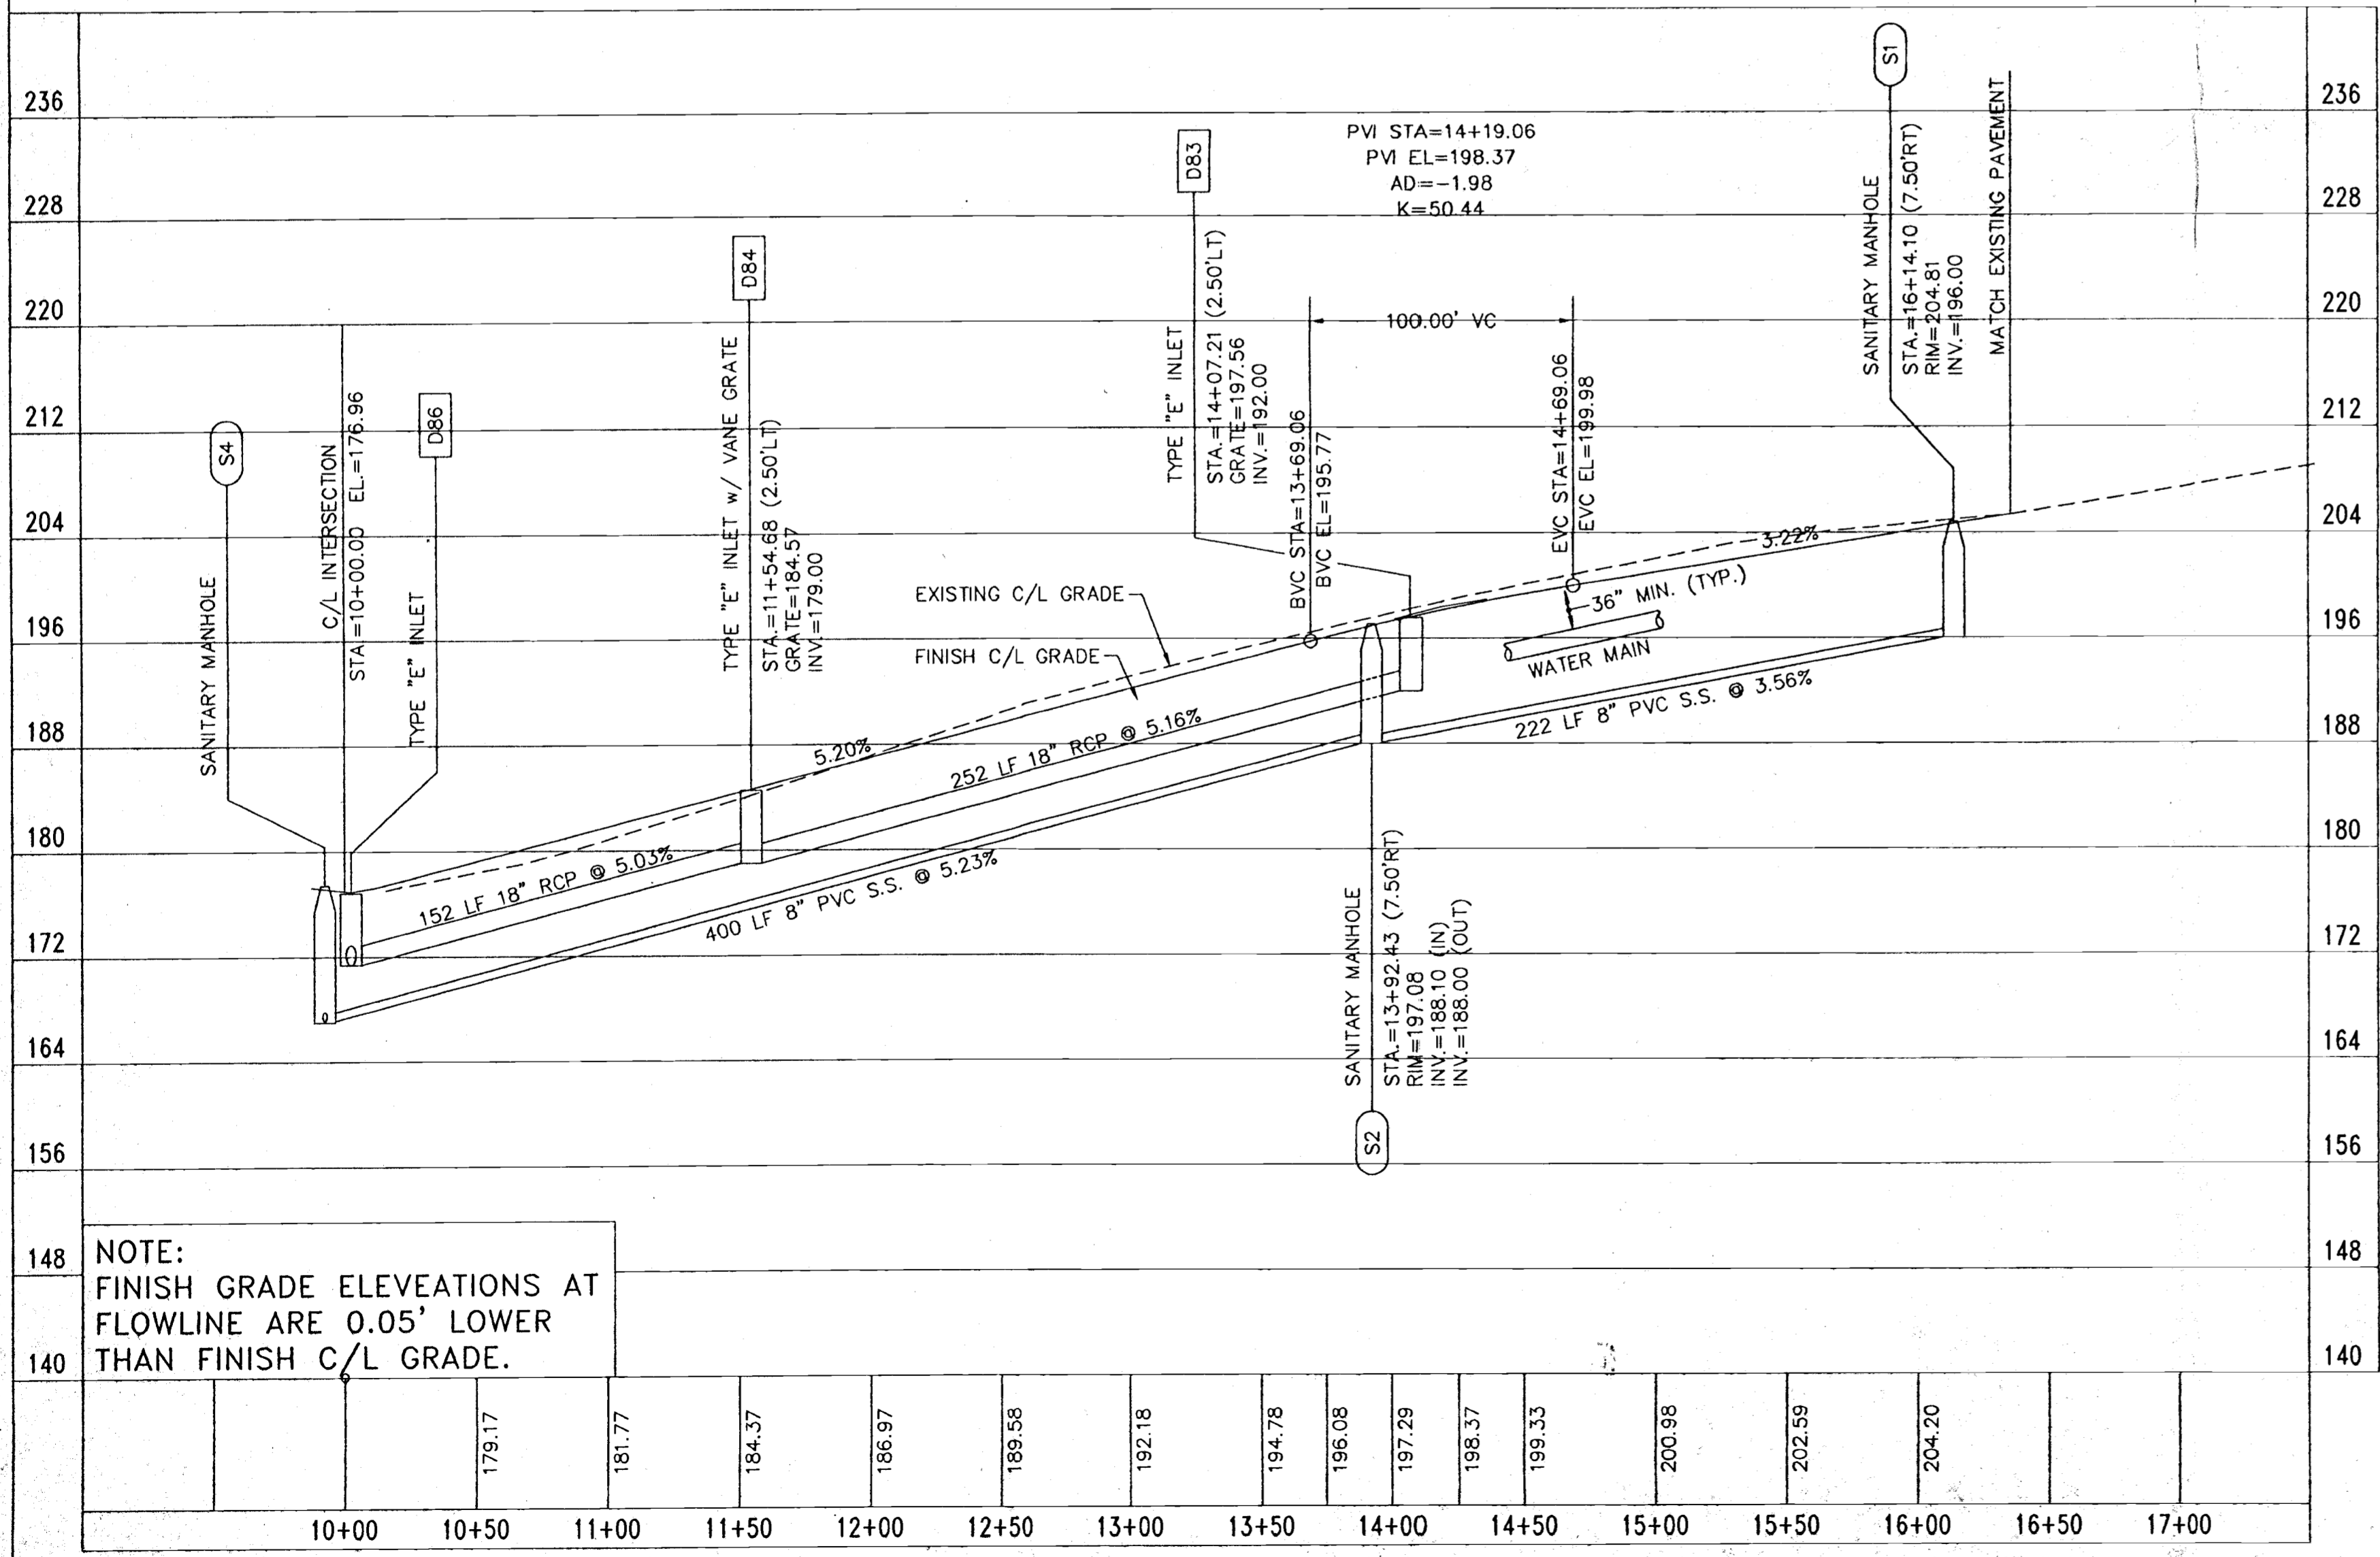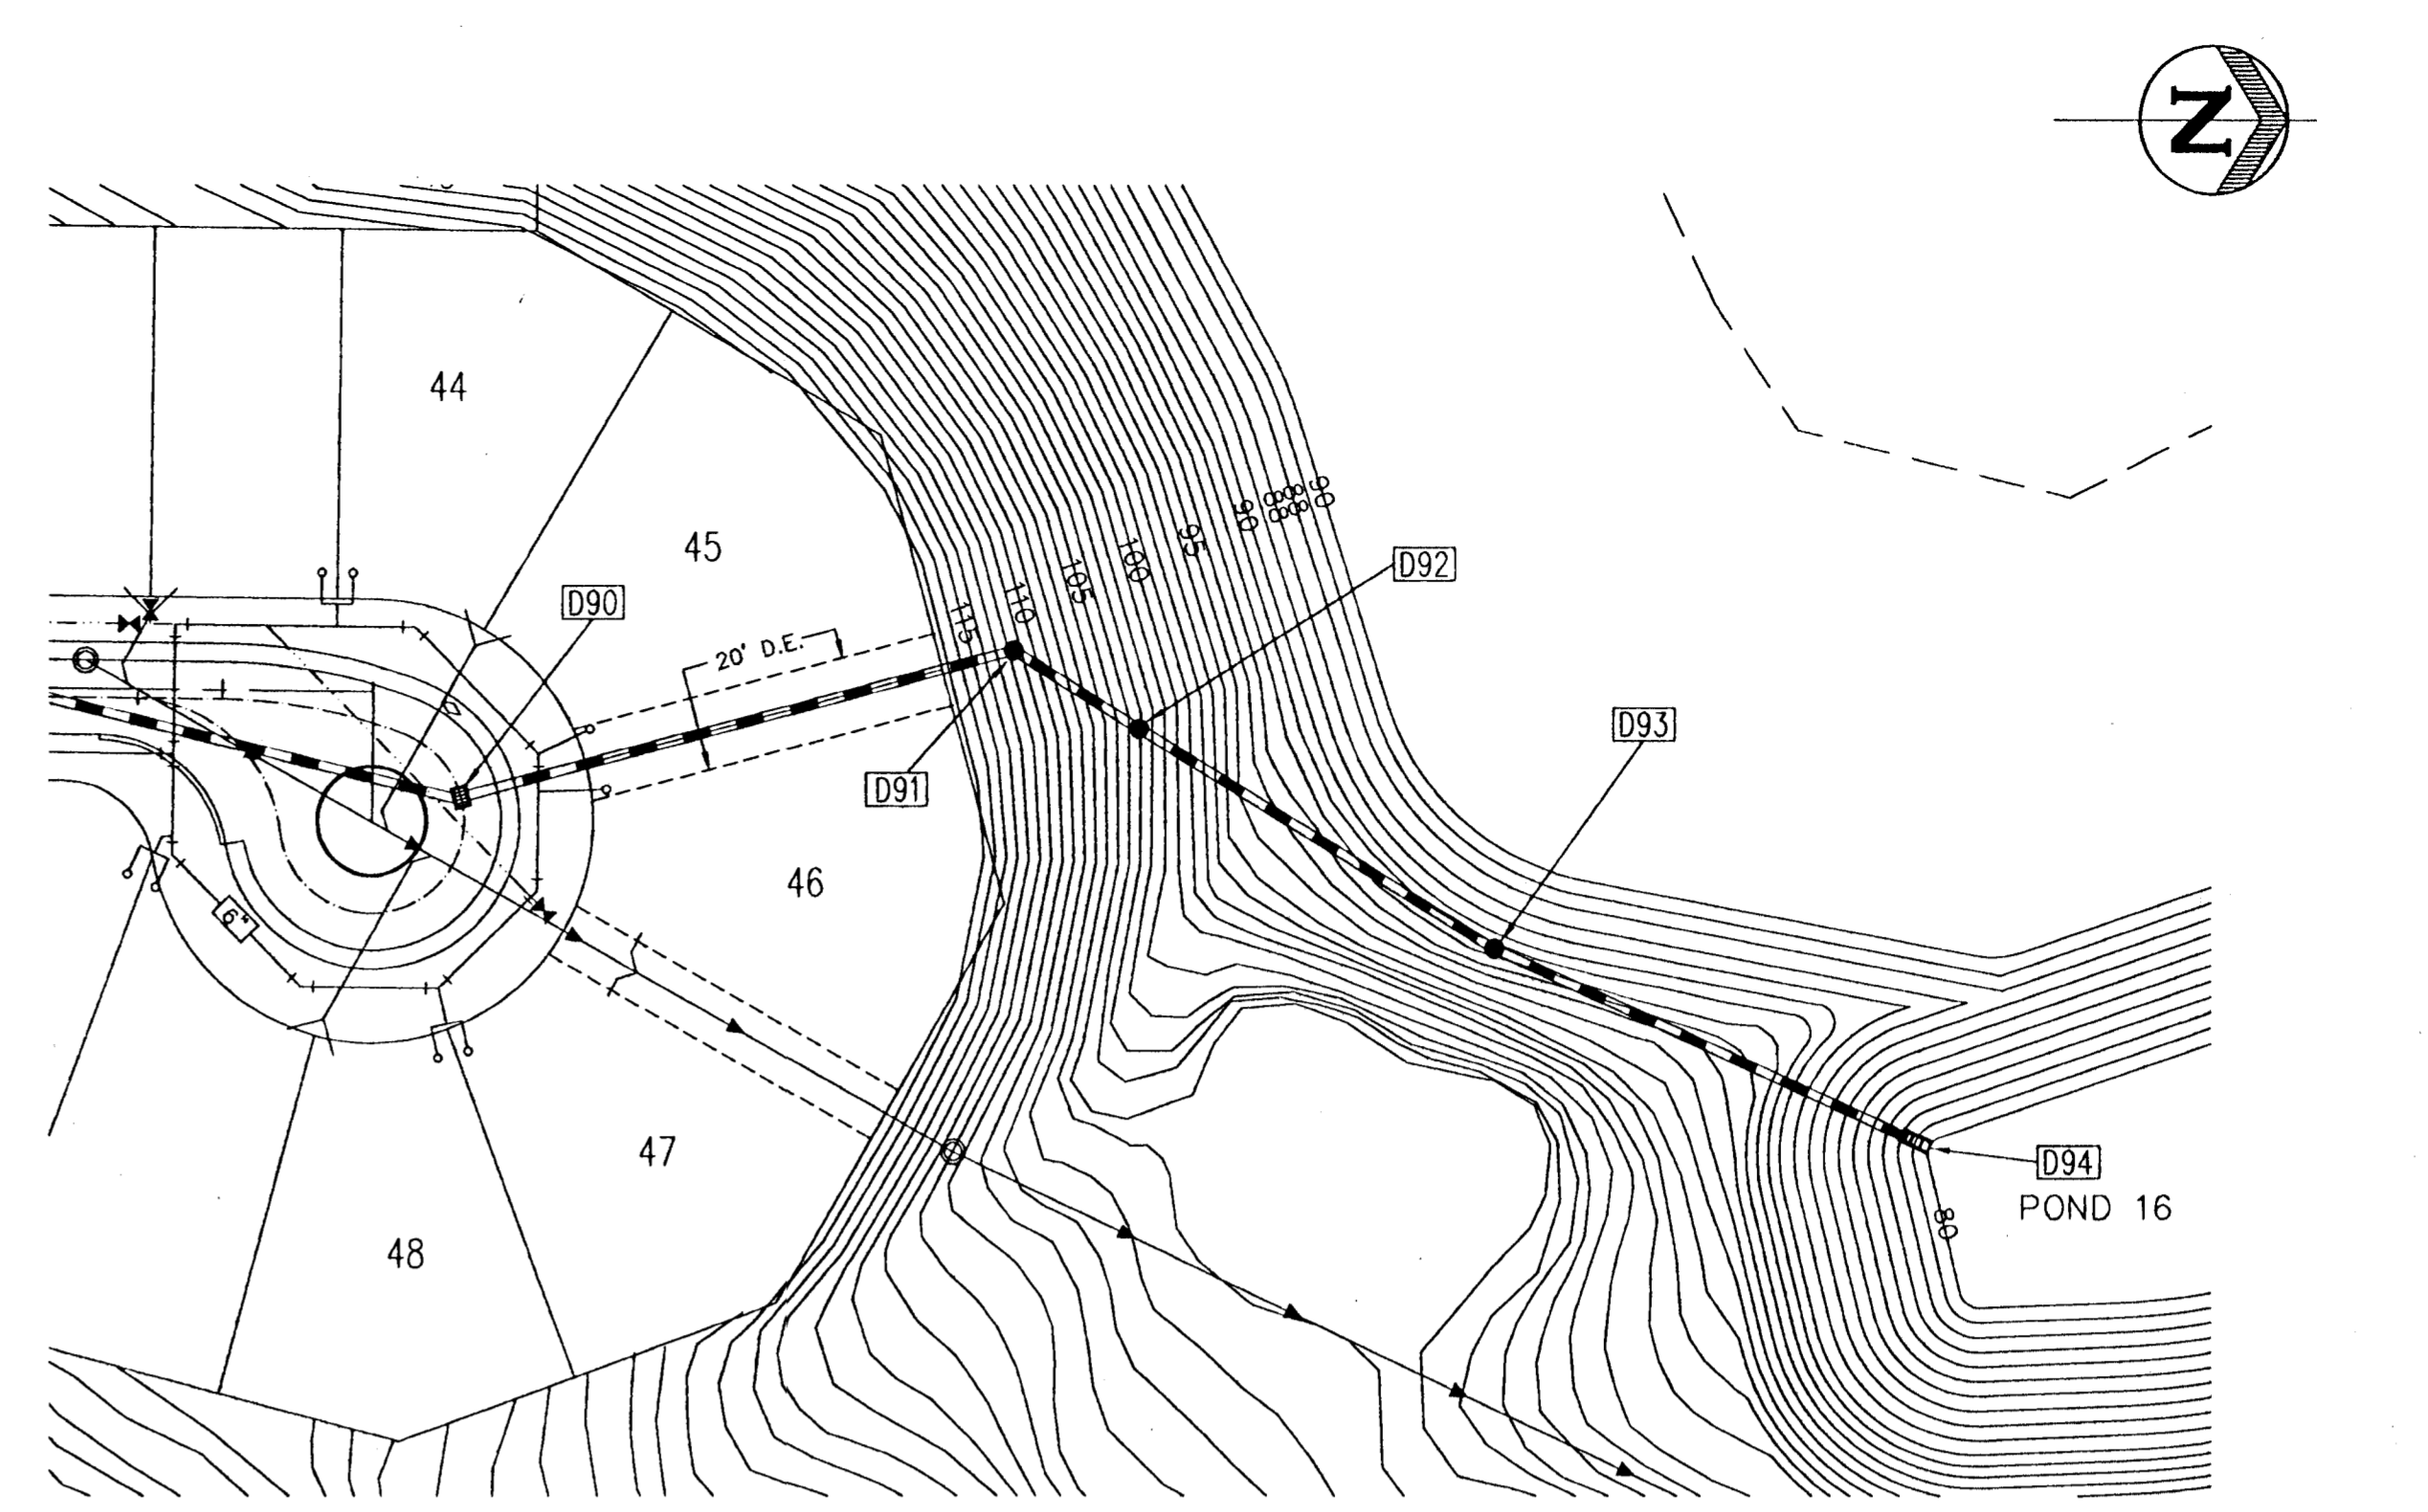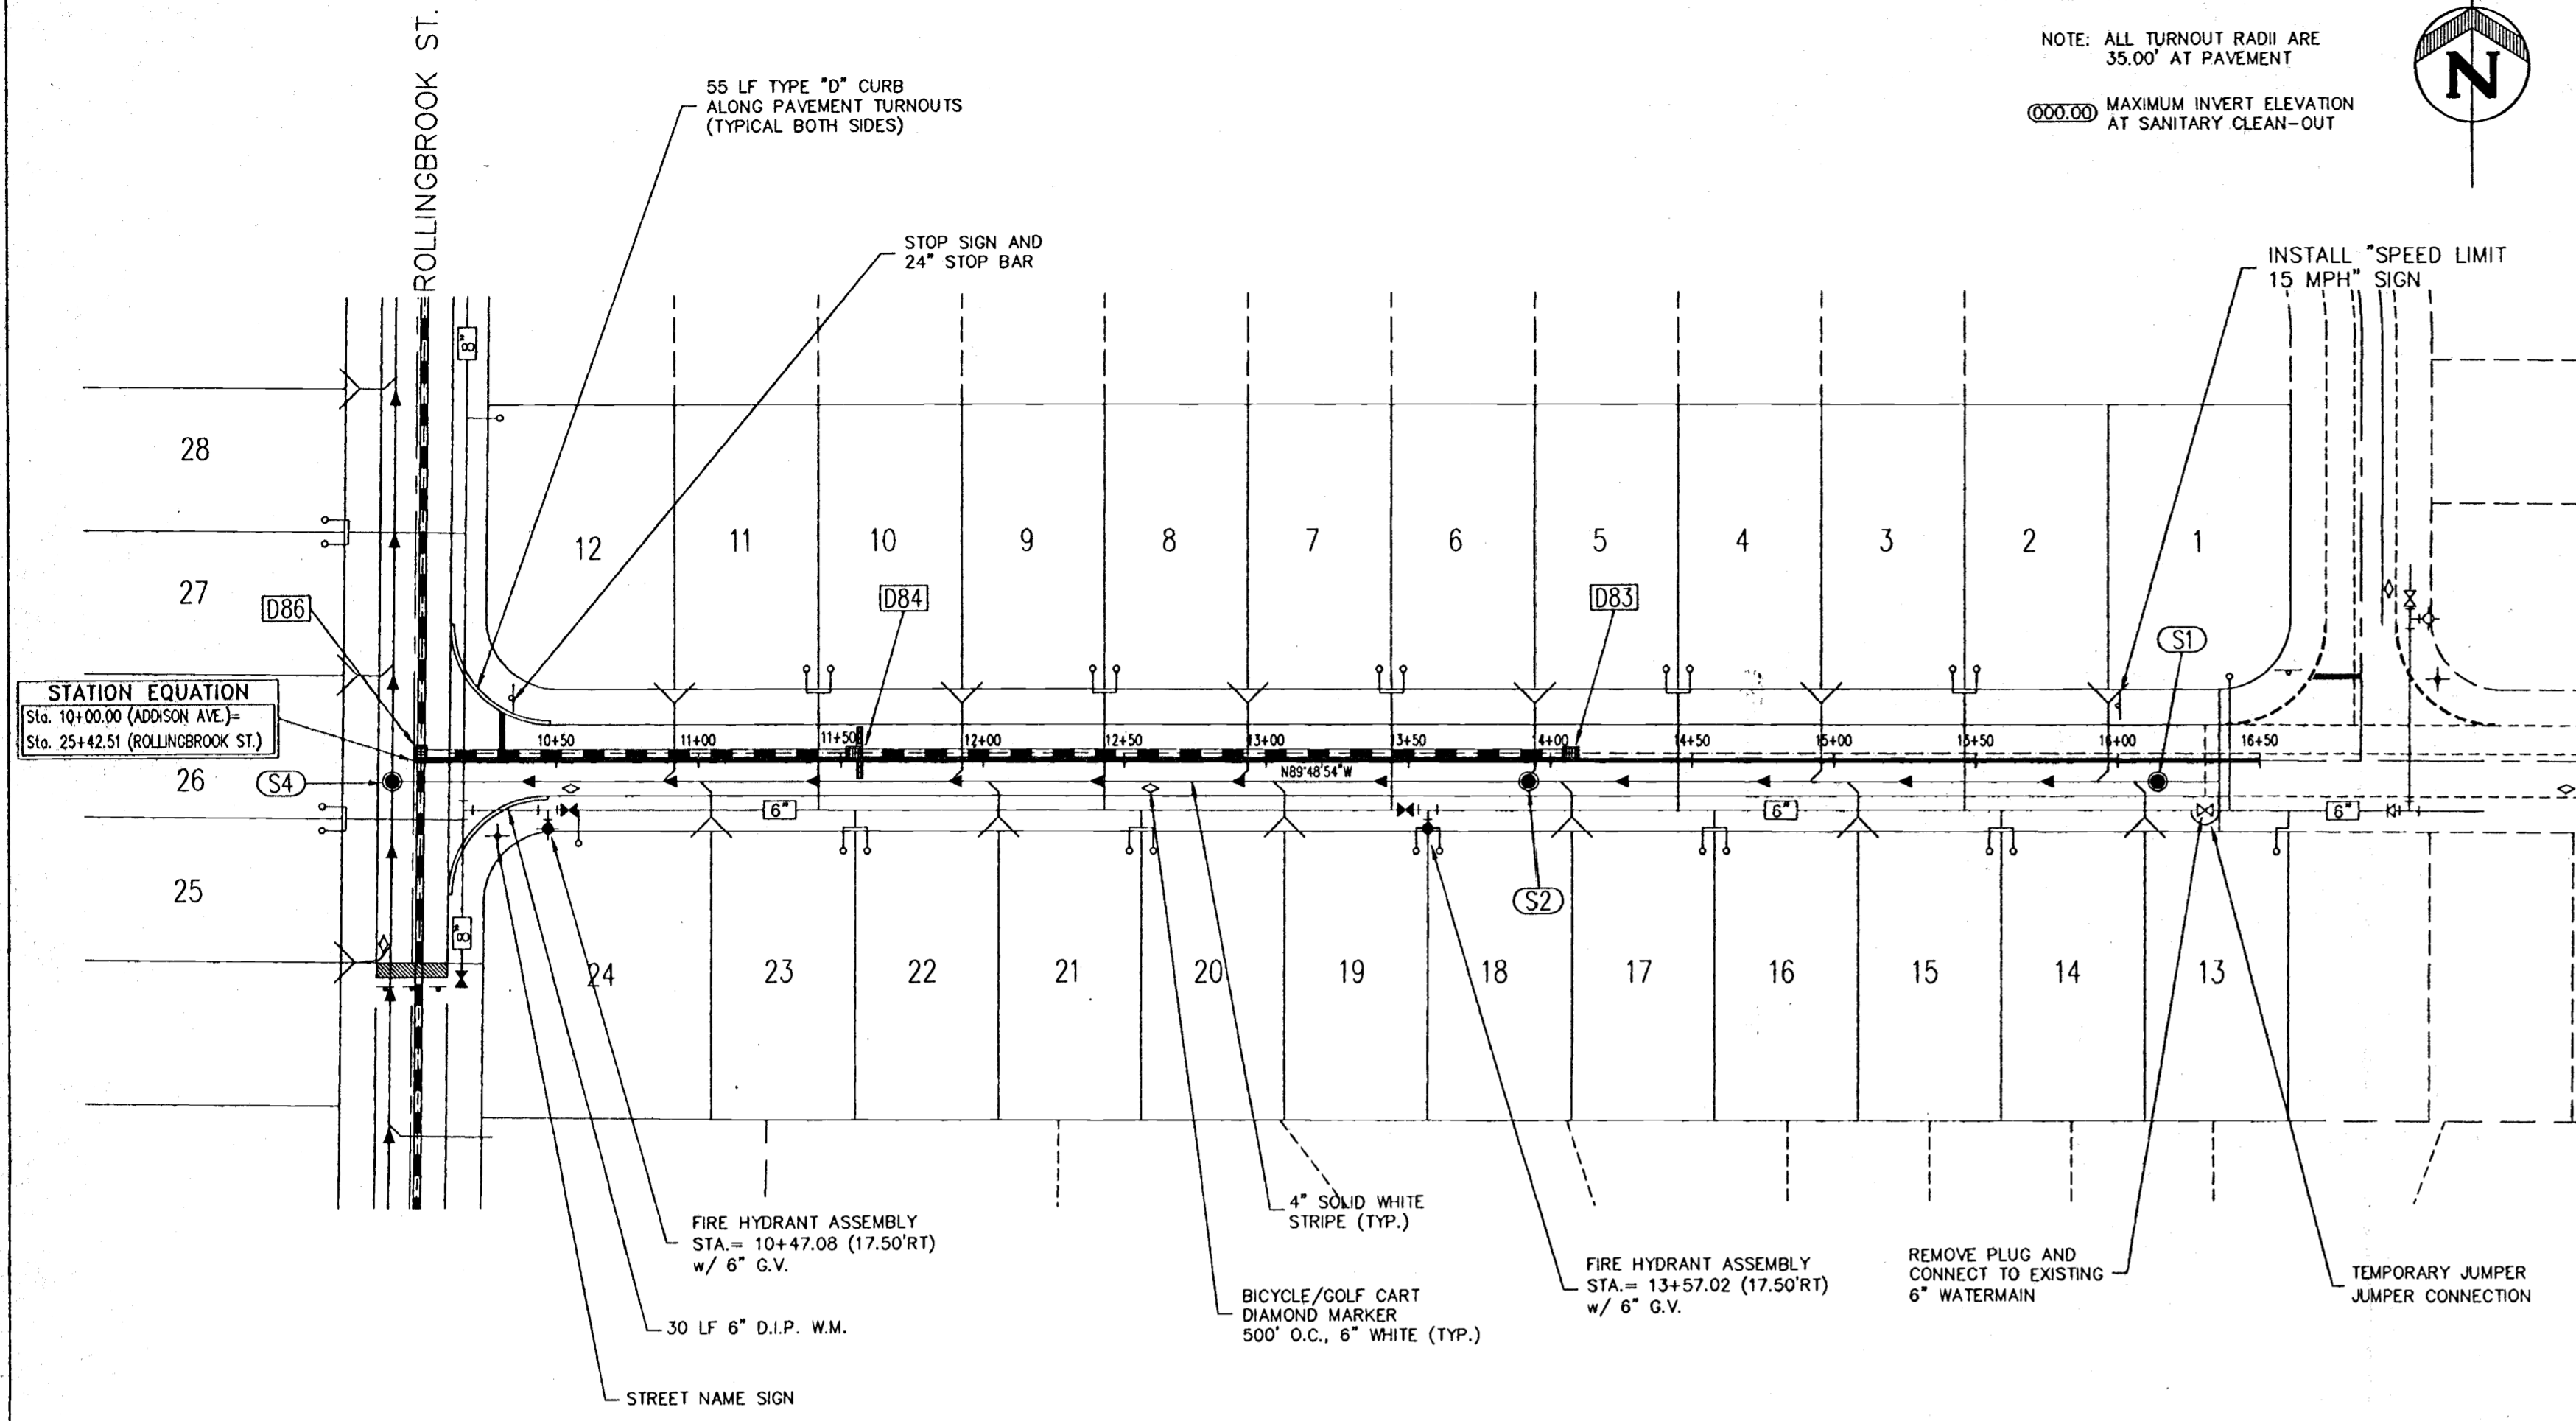

HORIZONTAL SCALE: 1"=50'  
 VERTICAL SCALE: 1"=10'

SCALE IN FEET

**ADDISON AVE.**

HORIZONTAL SCALE: 1"=50'  
 VERTICAL SCALE: 1"=10'

SCALE IN FEET

REVISION  
 DATE REVISION  
 1 7/12/00 MISC. CHANGES  
 2 8/2/00 RAISED GRADIS

ENGINEERS SURVEYORS PLANNERS  
**FARNER BARBLEY**  
 AND ASSOCIATES, INC.  
 350 North Sinclair Avenue O Tallahassee, Florida 32378 O (352) 343-8481

**PLAN AND PROFILE ABERDEEN PHASE II AT KINGS RIDGE**

CHECKED BY:  
 PROJECT NO.: 941216.104  
 DATE: APRIL 2000  
 DRAWN BY: JM

FILE **RECEIVED**  
 AUG 17 2000  
 PPS  
 AUG 16 2000

46-069-19411-11